



THE INFORMATION ON THIS DRAWING IS TO THE ORDNANCE SURVEY IRELAND ITM COORDINATE SYSTEM

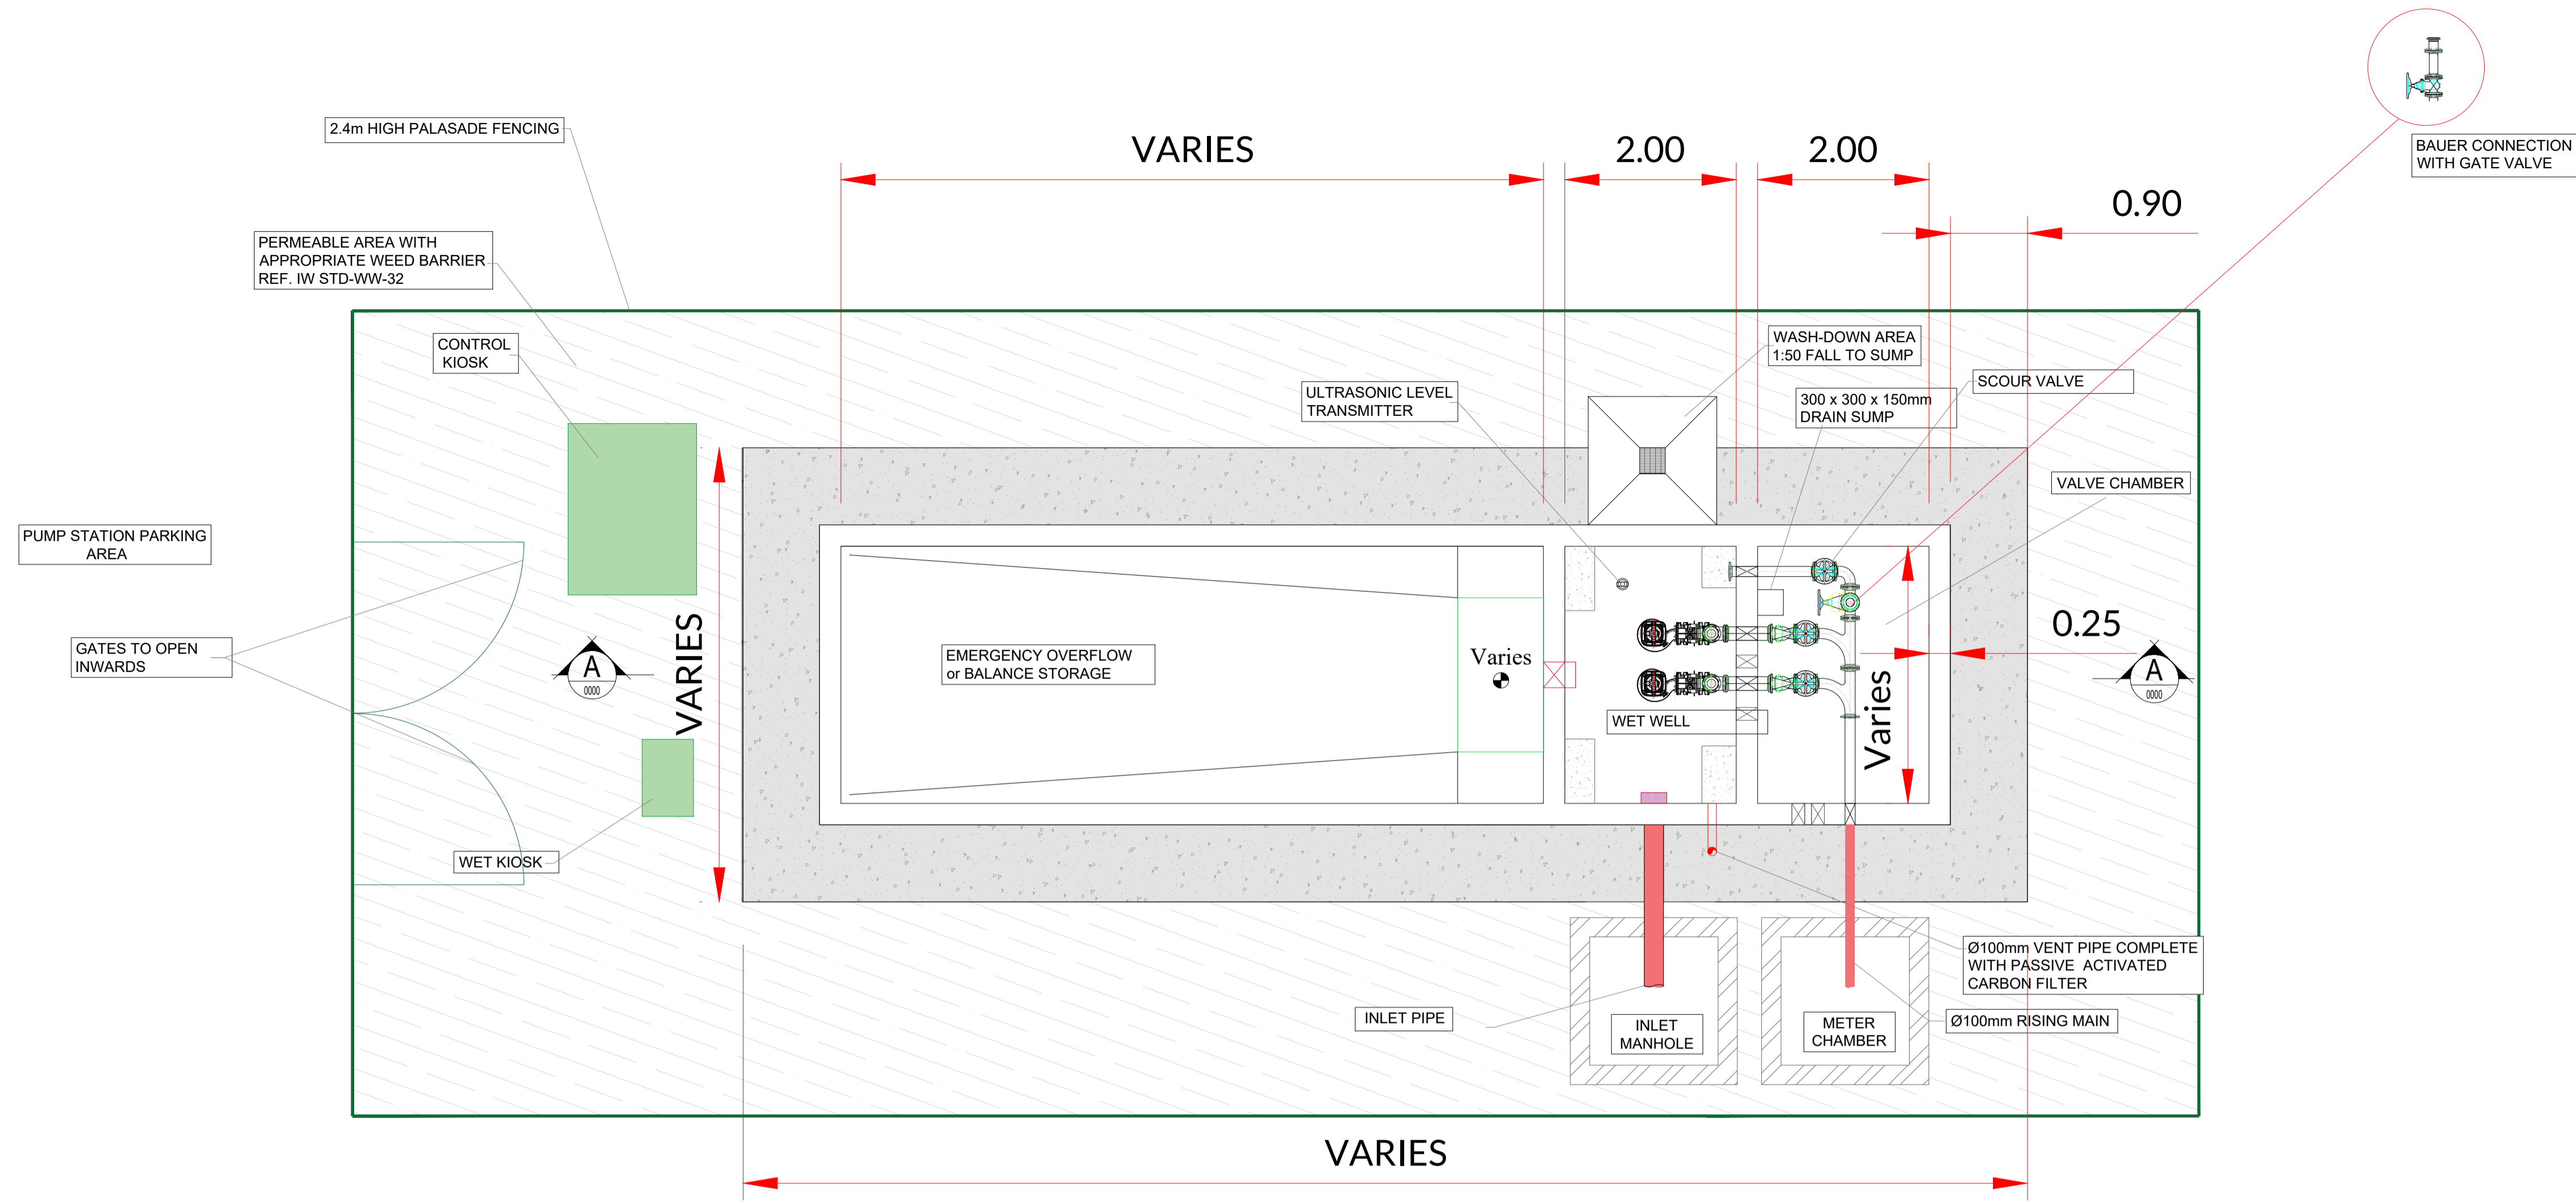

PUMP STATION PLAN VIEW

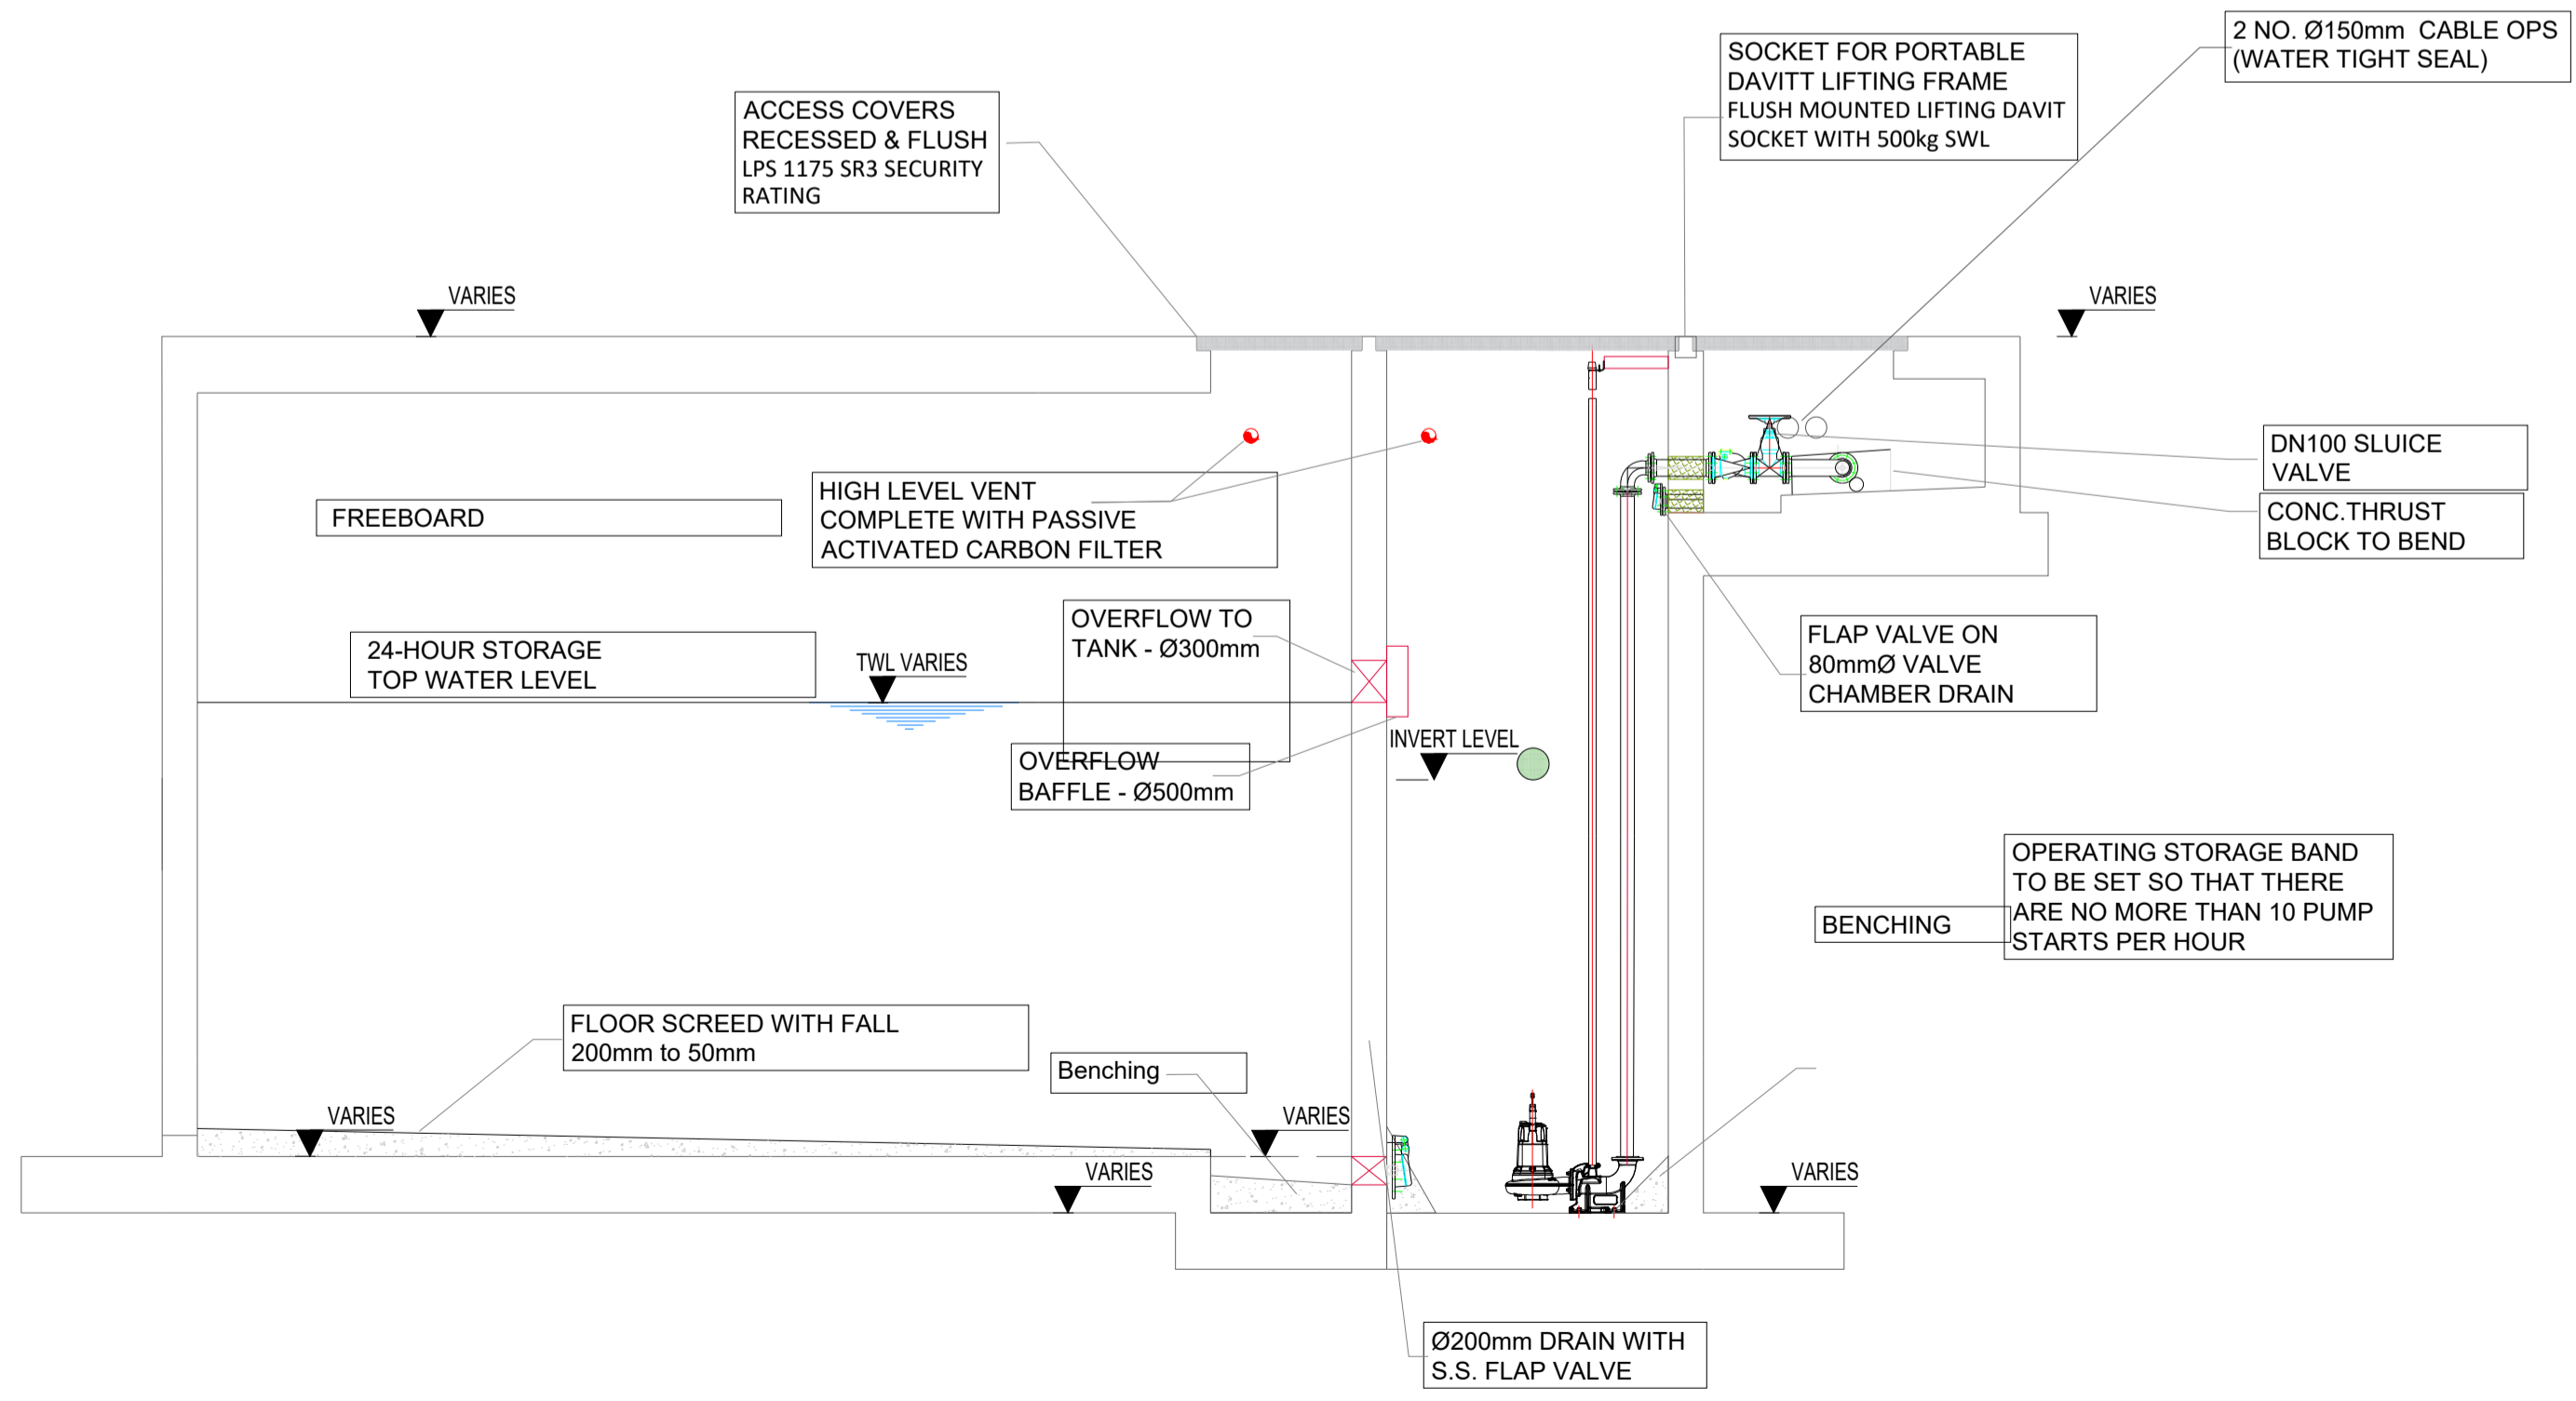

CROSS SECTION 'A' with Mechanical Details

- NOTES:
1. FIGURED DIMENSIONS ONLY TO BE TAKEN FROM THIS DRAWING.
 2. ALL DRAWINGS TO BE CHECKED BY THE CONTRACTOR ON SITE.
 3. ENGINEER/EMPLOYERS REPRESENTATIVE, AS APPROPRIATE, TO BE INFORMED BY THE CONTRACTOR OF ANY DISCREPANCIES BEFORE ANY WORK COMMENCES.
 4. THE CONTRACTOR SHALL UNDERTAKE A THOROUGH CHECK FOR THE ACTUAL LOCATION OF ALL SERVICES/UTILITIES, ABOVE AND BELOW GROUND, BEFORE ANY WORK COMMENCES.
 5. ALL LEVELS SHOWN RELATE TO ORDNANCE SURVEY DATUM AT MALIN HEAD.

Rev	Date	Description	By	Chkd.
P01	07.07.2022	Issued For Planning	MN	BH

Client: Lock House Development Ltd.

Project: Strategic Housing Development at Bothar an Choiste, Castlegar Galway,

Title: Typical Pump Station Details

Scale @ A1: 1:50 / @A3 1:100
 Prepared by: MN
 Checked by: BH
 Date: July 2022
 Project Director: Brian Carroll
 Drawing Status: Planning

TOBIN
 CONSULTING ENGINEERS
 Galway Office
 Fairgreen House, Fairgreen Road,
 Galway,
 H91 AXK8,
 Ireland.

Tel: +353 (0)91 565 211
 www.tobin.ie

Drawing No.: 10750-2124P01